


P:\PDX PROJECTS\2017\17-023 Kitsap County Parks - Waterless Restroom\CAD\2-Sheets\Civil\C-03_CIVIL SITE PLAN.dwg 9/7/2017 4:50 PM
 COPYRIGHT 2015, AKANA. ALL RIGHTS RESERVED

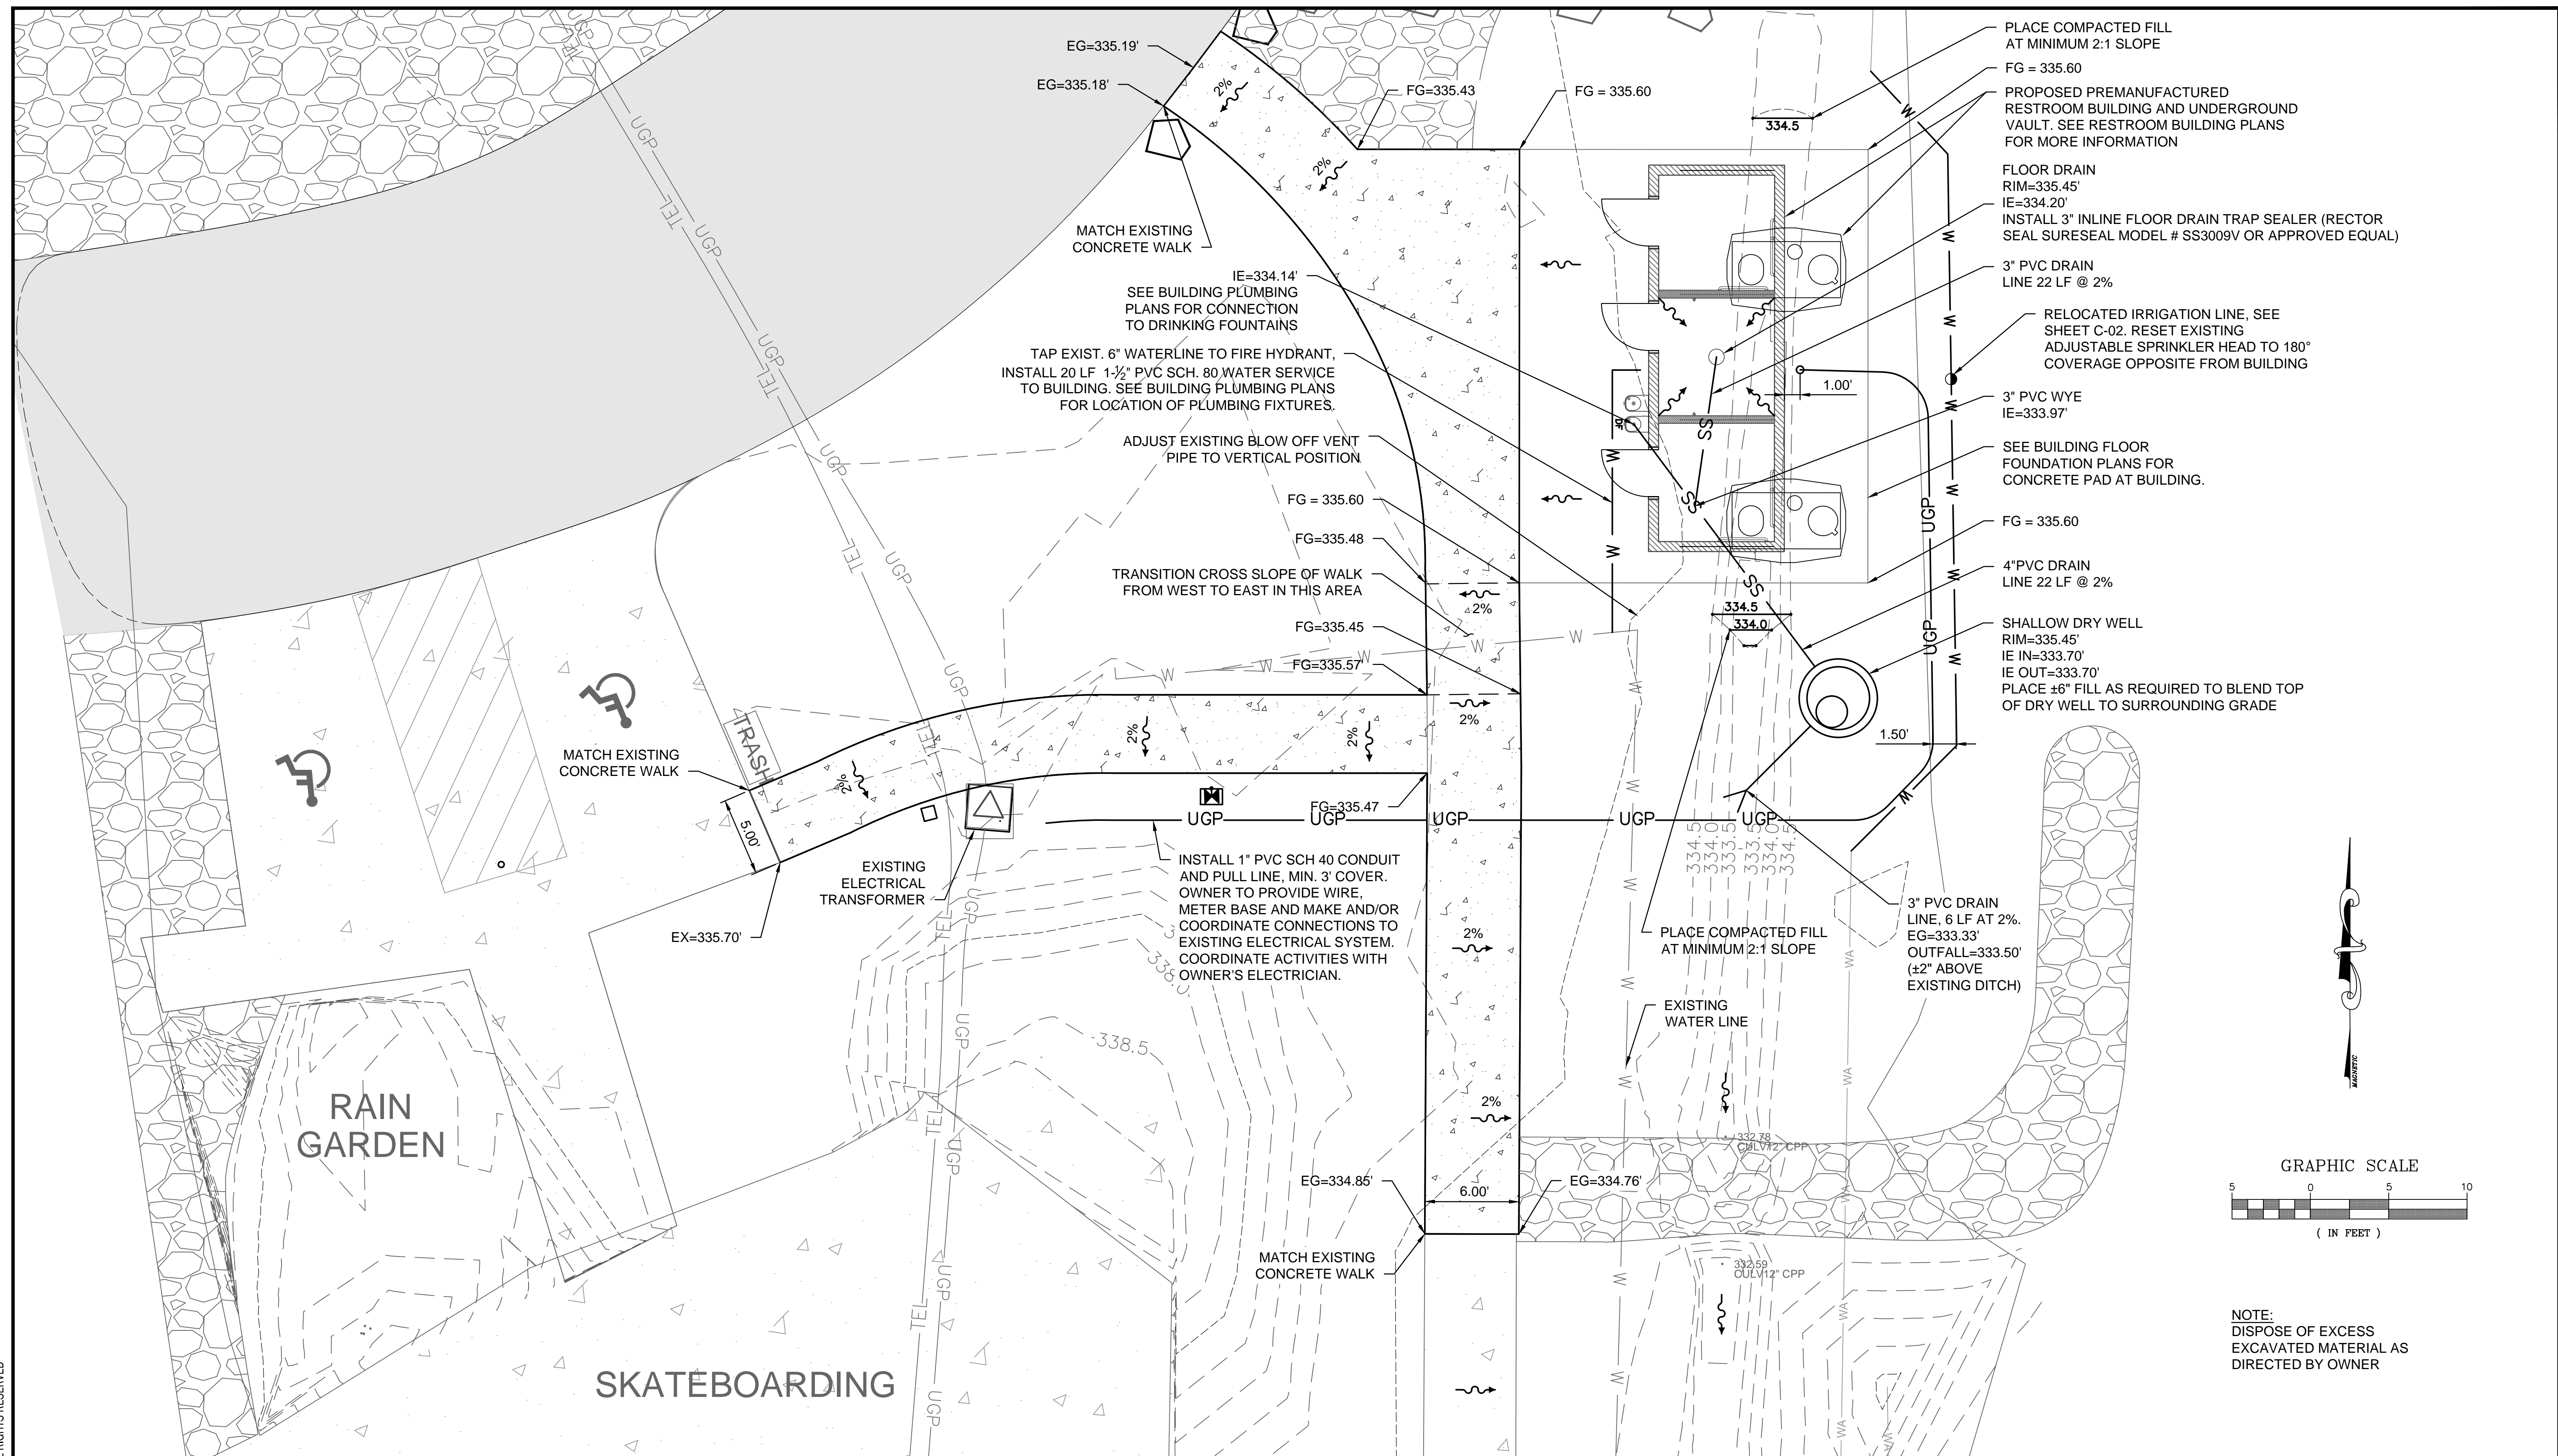

NO.	DATE	BY	REVISIONS

AKANA
 Plan + Design + Engineer + Manage




6400 SE Lake Road, Ste 270
 Portland, Oregon 97222
 Voice (503) 652-9090

KITSAP COUNTY PARKS DEPARTMENT

1195 NW FAIRGROUNDS RD.
 BREMERTON, WA 98311
 360-337-5350

DESIGNED BY	RPK
DRAWN BY	TLH
CHECKED BY	CZ
DRAWING DATE	07/14/2017

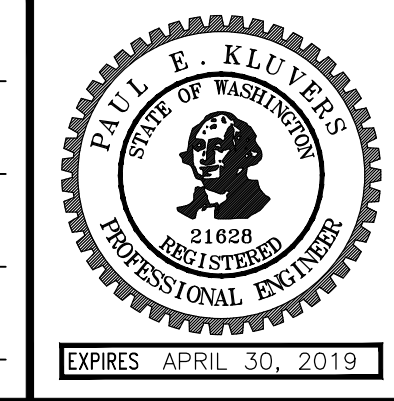

SOUTH KITSAP REGIONAL PARK
WATERLESS RESTROOM
CIVIL SITE PLAN

JOB NO. 17-023
 SHEET NO. **C-03**
 3 OF 4